


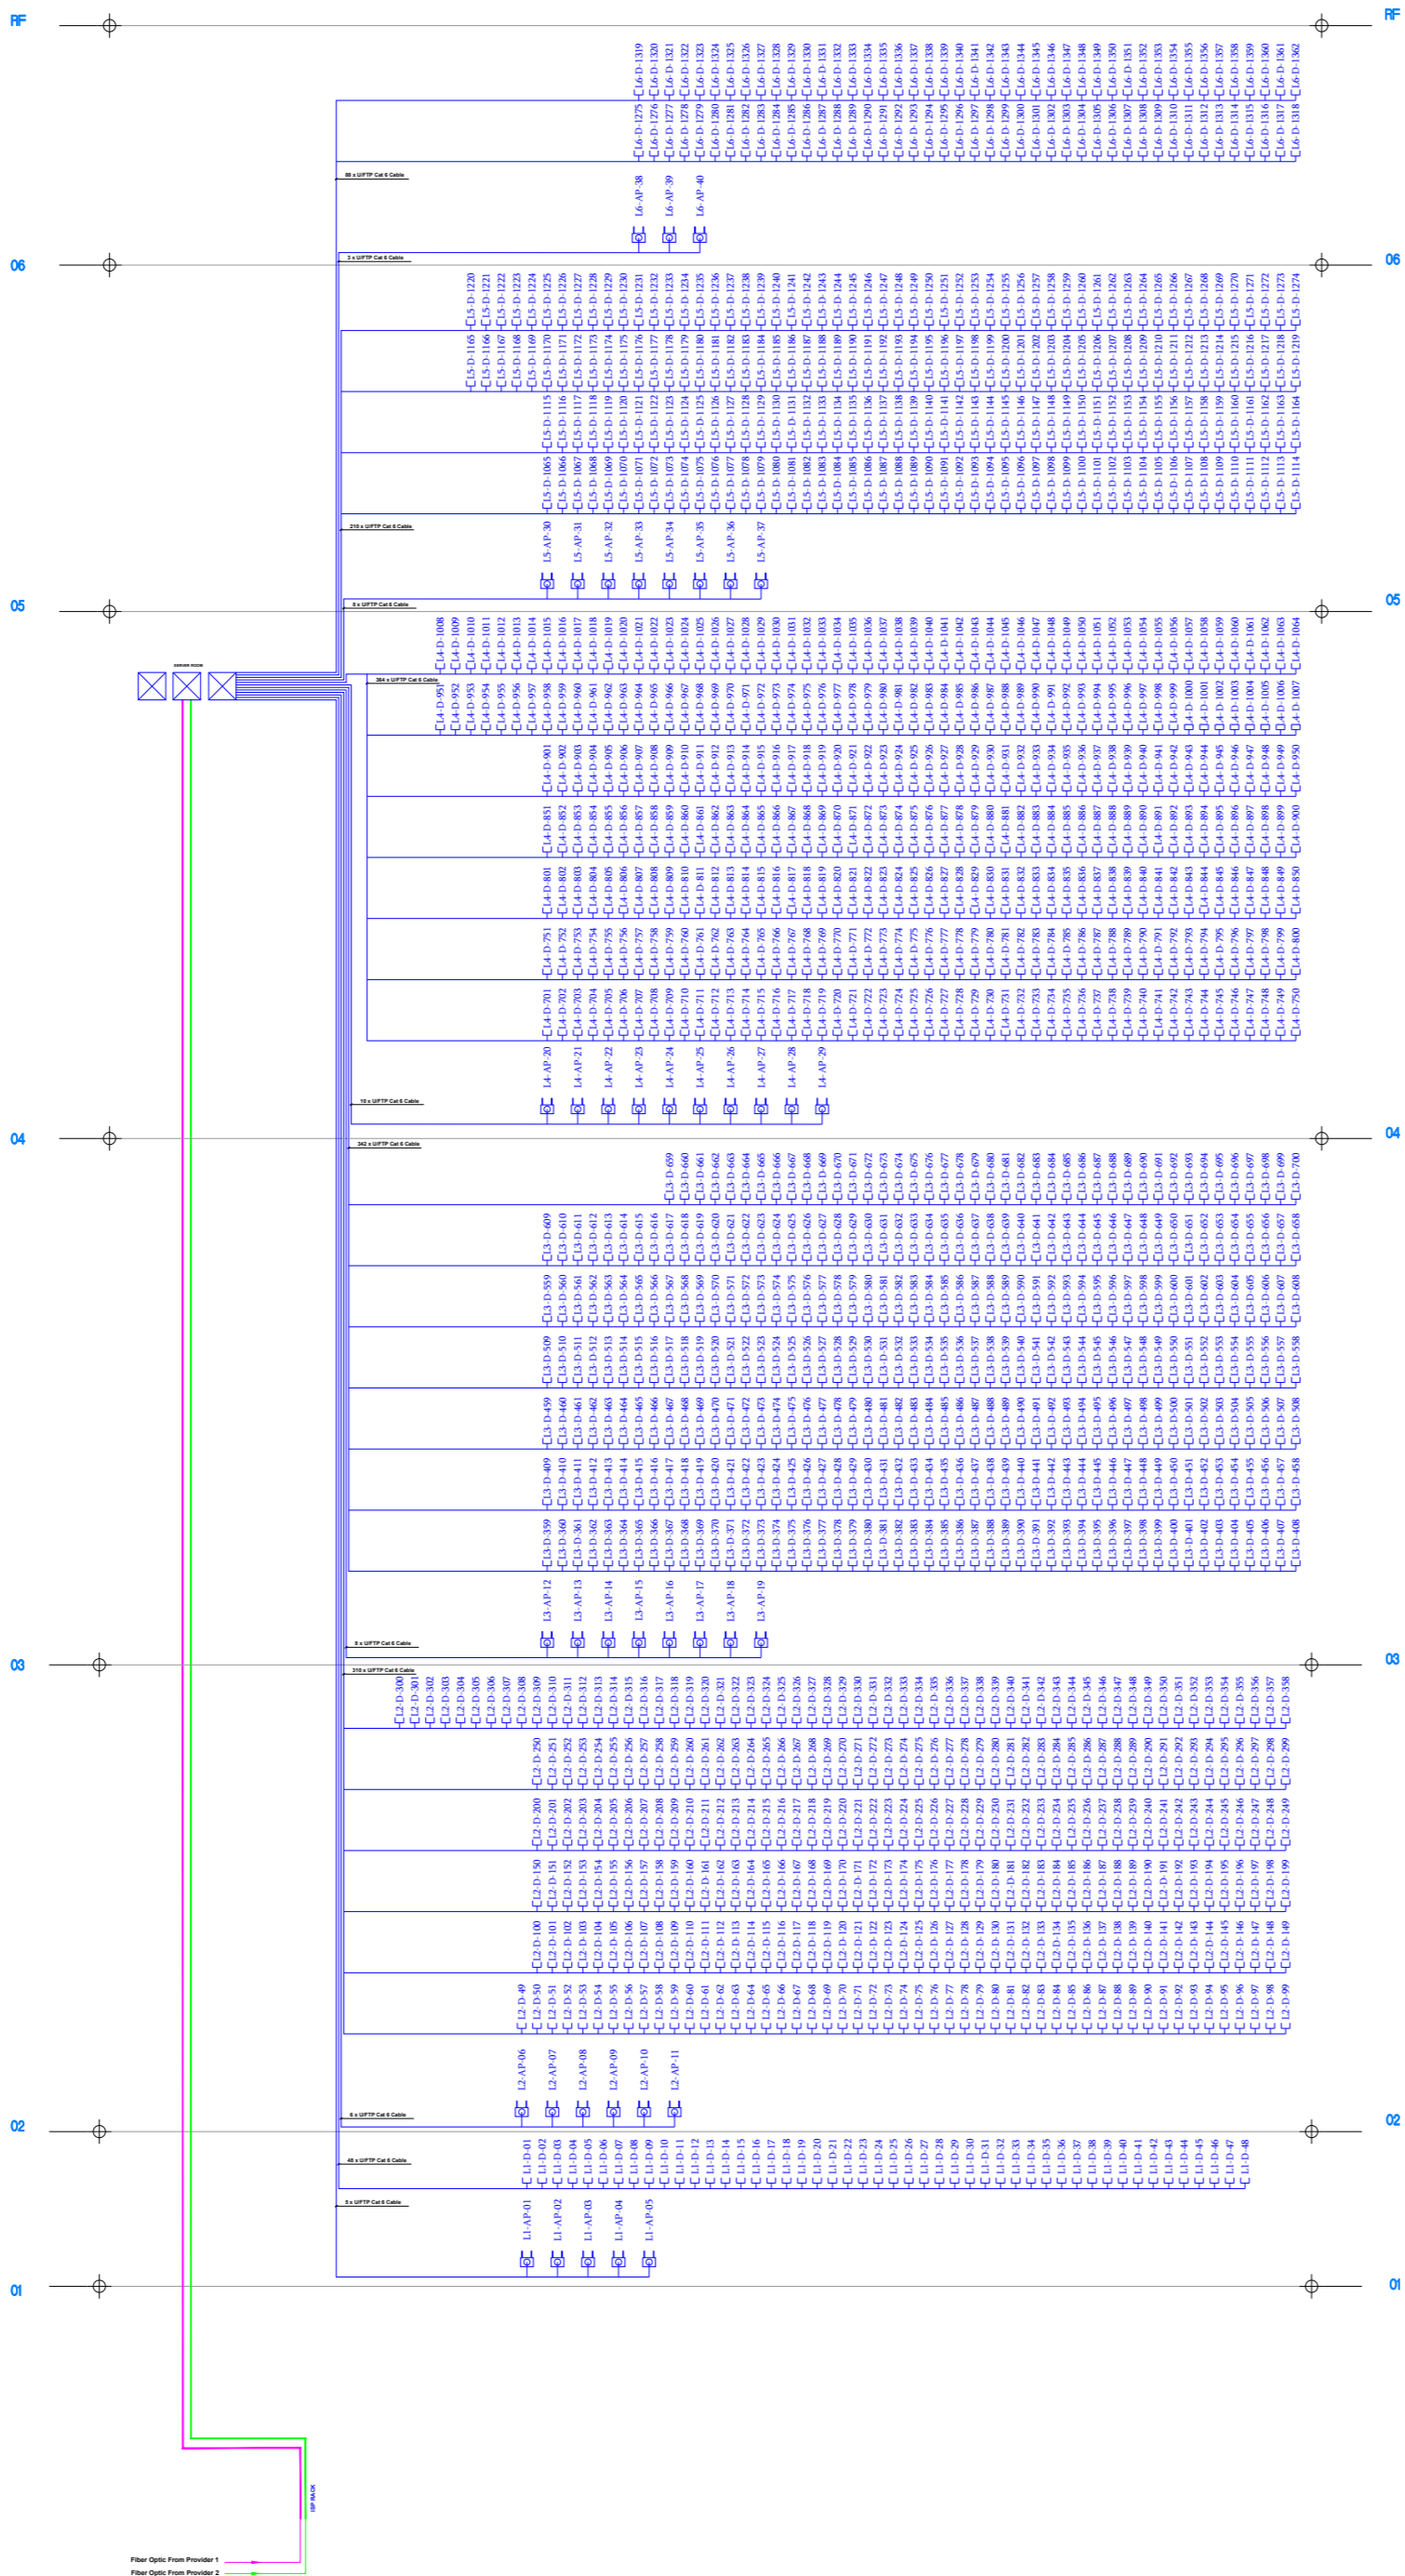

Telecommunication Rack



Cat 6 U/FTP LSHP outlet



Client

Address

City

Country

Phone

LLC insta

10 Krasnaya Street, 4077 Tbilisi

551 500 521 0000

Email: info@insta.ge

instaloelectricalsolutions

Project Proposal

Sheet No.

Sheet Title

Sheet Date

Revision

Project Name

One Line Diagram - Telecom and Wi-Fi System

Scale

1:100

Drawn By

HALIMASHVILI

Checked By

Levanashvili

Reviewed By

Levanashvili

Approved By

Levanashvili

Issue Date

2023-03-20

Revision

0